

LEGEND

- - - - - PROPERTY LINE

JB - JUNCTION BOX



GREENTECH RENEWABLES

CONTRACTOR



FARLEY BUILT, INC.

PROJECT NAME & ADDRESS

HAYNES
 32 VINEYARD MEADOW FARMS RD, WEST TISBURY, MA 02575, USA

SIGNATURE WITH SEAL


sealed 01dec2022 mike@h2dc.com
 H2DC PLLC MA CoA#: 001239603
 ELECTRICAL ONLY
 - NOT AN AS BUILT DRAWING SET -

REV	DESCRIPTION	DATE
A	PERMIT PLAN	12/01/2022


SHEET TITLE
SITE PLAN

DRAWN DATE	12/01/2022
DRAWN BY	JK
REVIEWED BY	VN

SHEET NUMBER
A-101

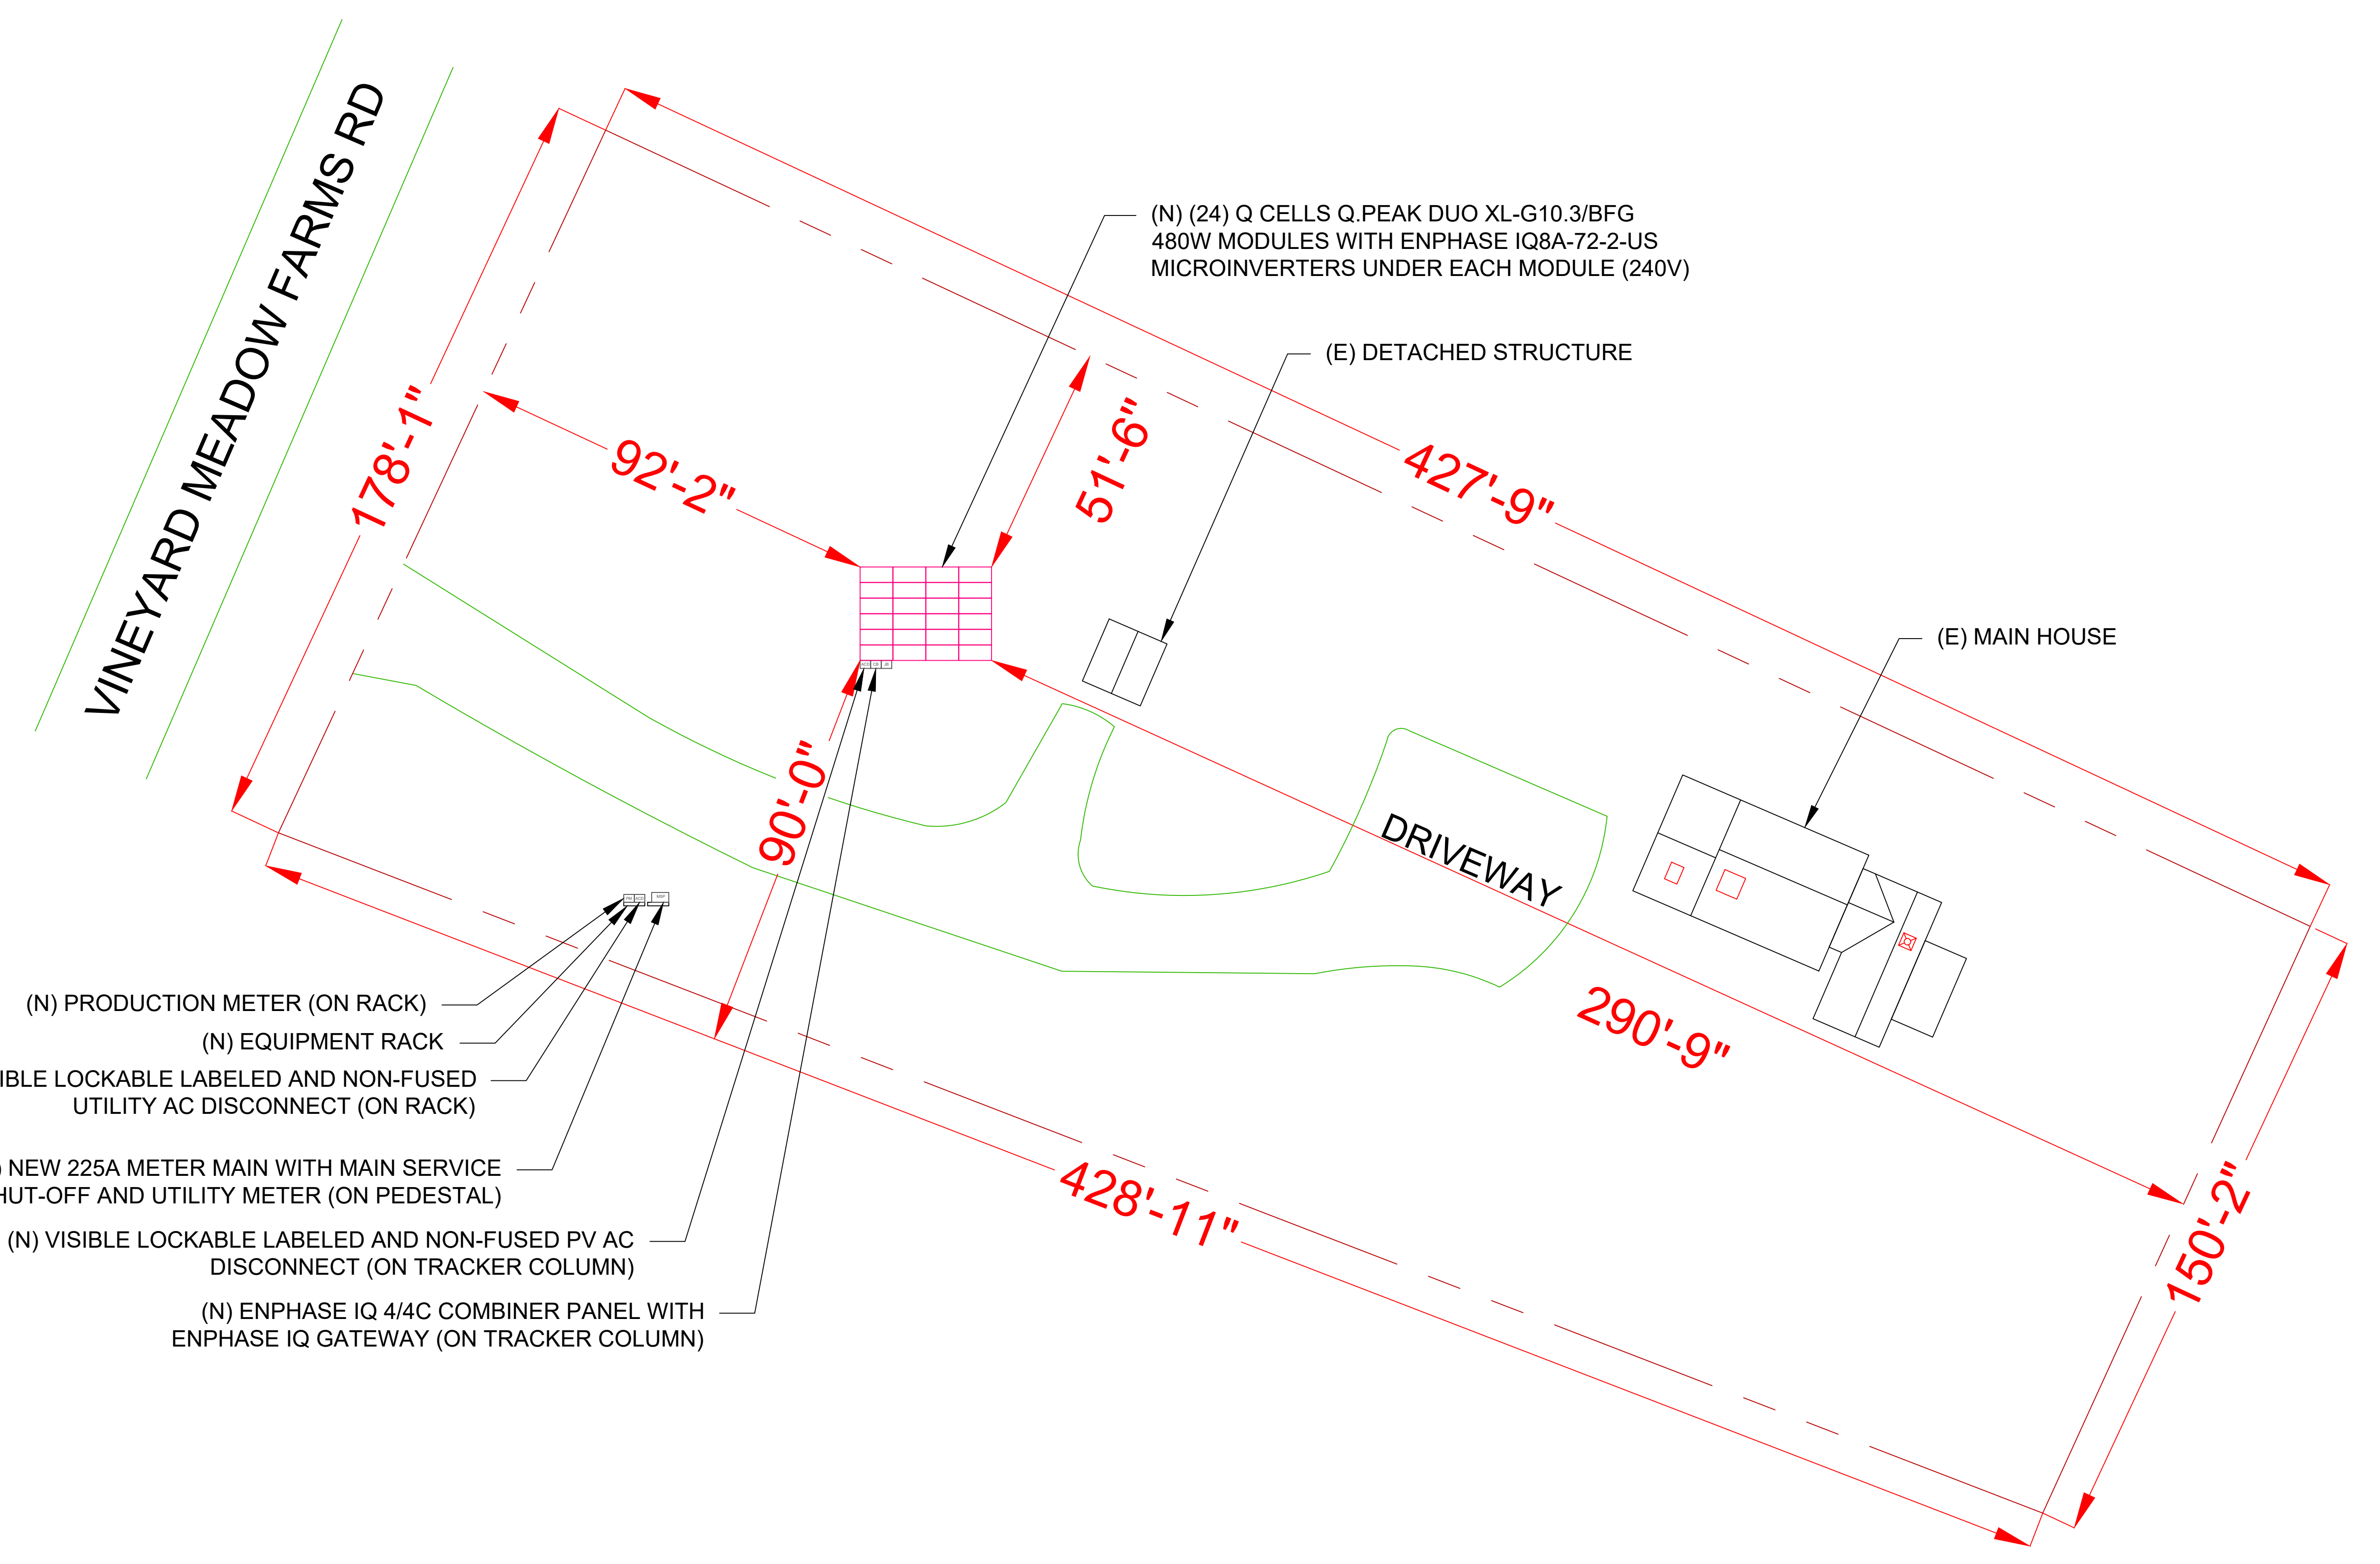

- (N) PRODUCTION METER (ON RACK)
- (N) EQUIPMENT RACK
- (N) VISIBLE LOCKABLE LABELED AND NON-FUSED UTILITY AC DISCONNECT (ON RACK)
- (N) NEW 225A METER MAIN WITH MAIN SERVICE SHUT-OFF AND UTILITY METER (ON PEDESTAL)
- (N) VISIBLE LOCKABLE LABELED AND NON-FUSED PV AC DISCONNECT (ON TRACKER COLUMN)
- (N) ENPHASE IQ 4/4C COMBINER PANEL WITH ENPHASE IQ GATEWAY (ON TRACKER COLUMN)

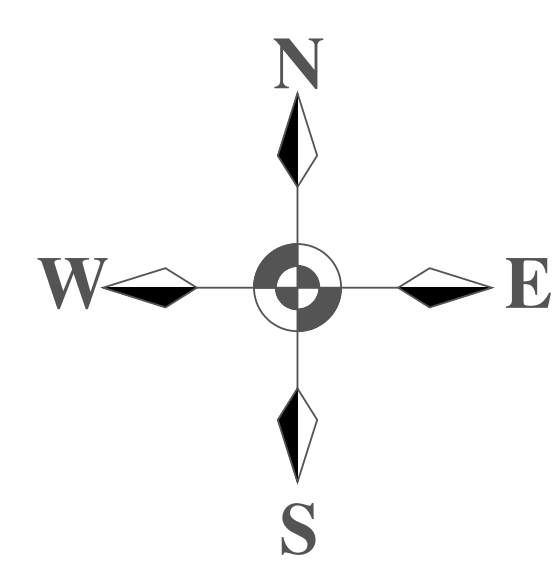

1 | SITE PLAN
SCALE: 1"=20'-0"