

STILLPOINT MEADOWS BARN

DRAWING INDEX	
A-00	Site Plan
A-01	Ground Floor + Basement Plan
A-02	Omitted
A-03	South & West Elevations
A-04	North & East Elevations
A-05	Building Sections
A-06	Building Sections
A-07	Details
A-08	Timber Frame Details
A-09	Details
A-10	Details
A-11	Details
A-12	Interior Elevations
A-13	Details
A-14	Door Details
A-15	Door Details
A-16	Omitted
A-17	Porch Timber Frame Details
A-18	Air Barrier Drawings
S-01	Foundation Plan
S-02	Foundation Details
S-03	Roof Framing Plan
S-04	Floor Slab Diagram
ME-01	Electrical Plans
ME-02	Mechanical Plans
ME-03	Mechanical System Details
ME-04	Omitted
ME-05	Omitted
ME-06	PV Layout Diagram
ME-07	Heat Storage Wiring Diagram
ME-08	Radiant Heating Diagram

DESIGNER & BUILDER:
 South Mountain Company
 Matt Coffey, Project Manager
 Rocco Bellebuono, Foreman, MA CS # 98941
 P.O. Box 1024
 West Tisbury, MA 02575
 508-693-4850

CIVIL ENGINEER:
 Vineyard Land Surveying +
 Engineering, Inc.
 12 Coumoyer Rd.
 P.O. Box 421
 West Tisbury, MA 02575
 508-693-3774

STRUCTURAL & TIMBERFRAME ENGINEER:
 Fire Tower Engineered Timber
 Ben Brungraber, PhD, P.E.
 60 Valley St., Unit 1
 Providence, RI 02909
 401-654-4600

BUILDING SYSTEMS ENGINEER:
 South Mountain Company
 Marc Rosenbaum, P.E.
 P.O. Box 1024
 West Tisbury, MA 02575
 508-693-4850

PLUMBING INSTALLER:
 Ralph Norton
 PO Box 339
 Oak Bluffs, MA 02557
 508.939.0100


LIGHTING CONSULTANT:
 Conceptual Lighting, LLC
 Peter Romaniello
 479 Clark St.
 South Windsor, CT 06074
 860.644.4358

ELECTRICIAN:
 Perry Electric
 Bob Perry
 312 State Road Vineyard
 Haven, MA 02568
 (508) 693-6557


Project Info
Stillpoint Meadows Barn
 Stillpoint Meadows Rd. West Tisbury, MA

Date: 12/26/12
 Scale: As Noted
 Revision: Date & Type
 CONSTRUCTION SET: 03.20.12


Sheet:

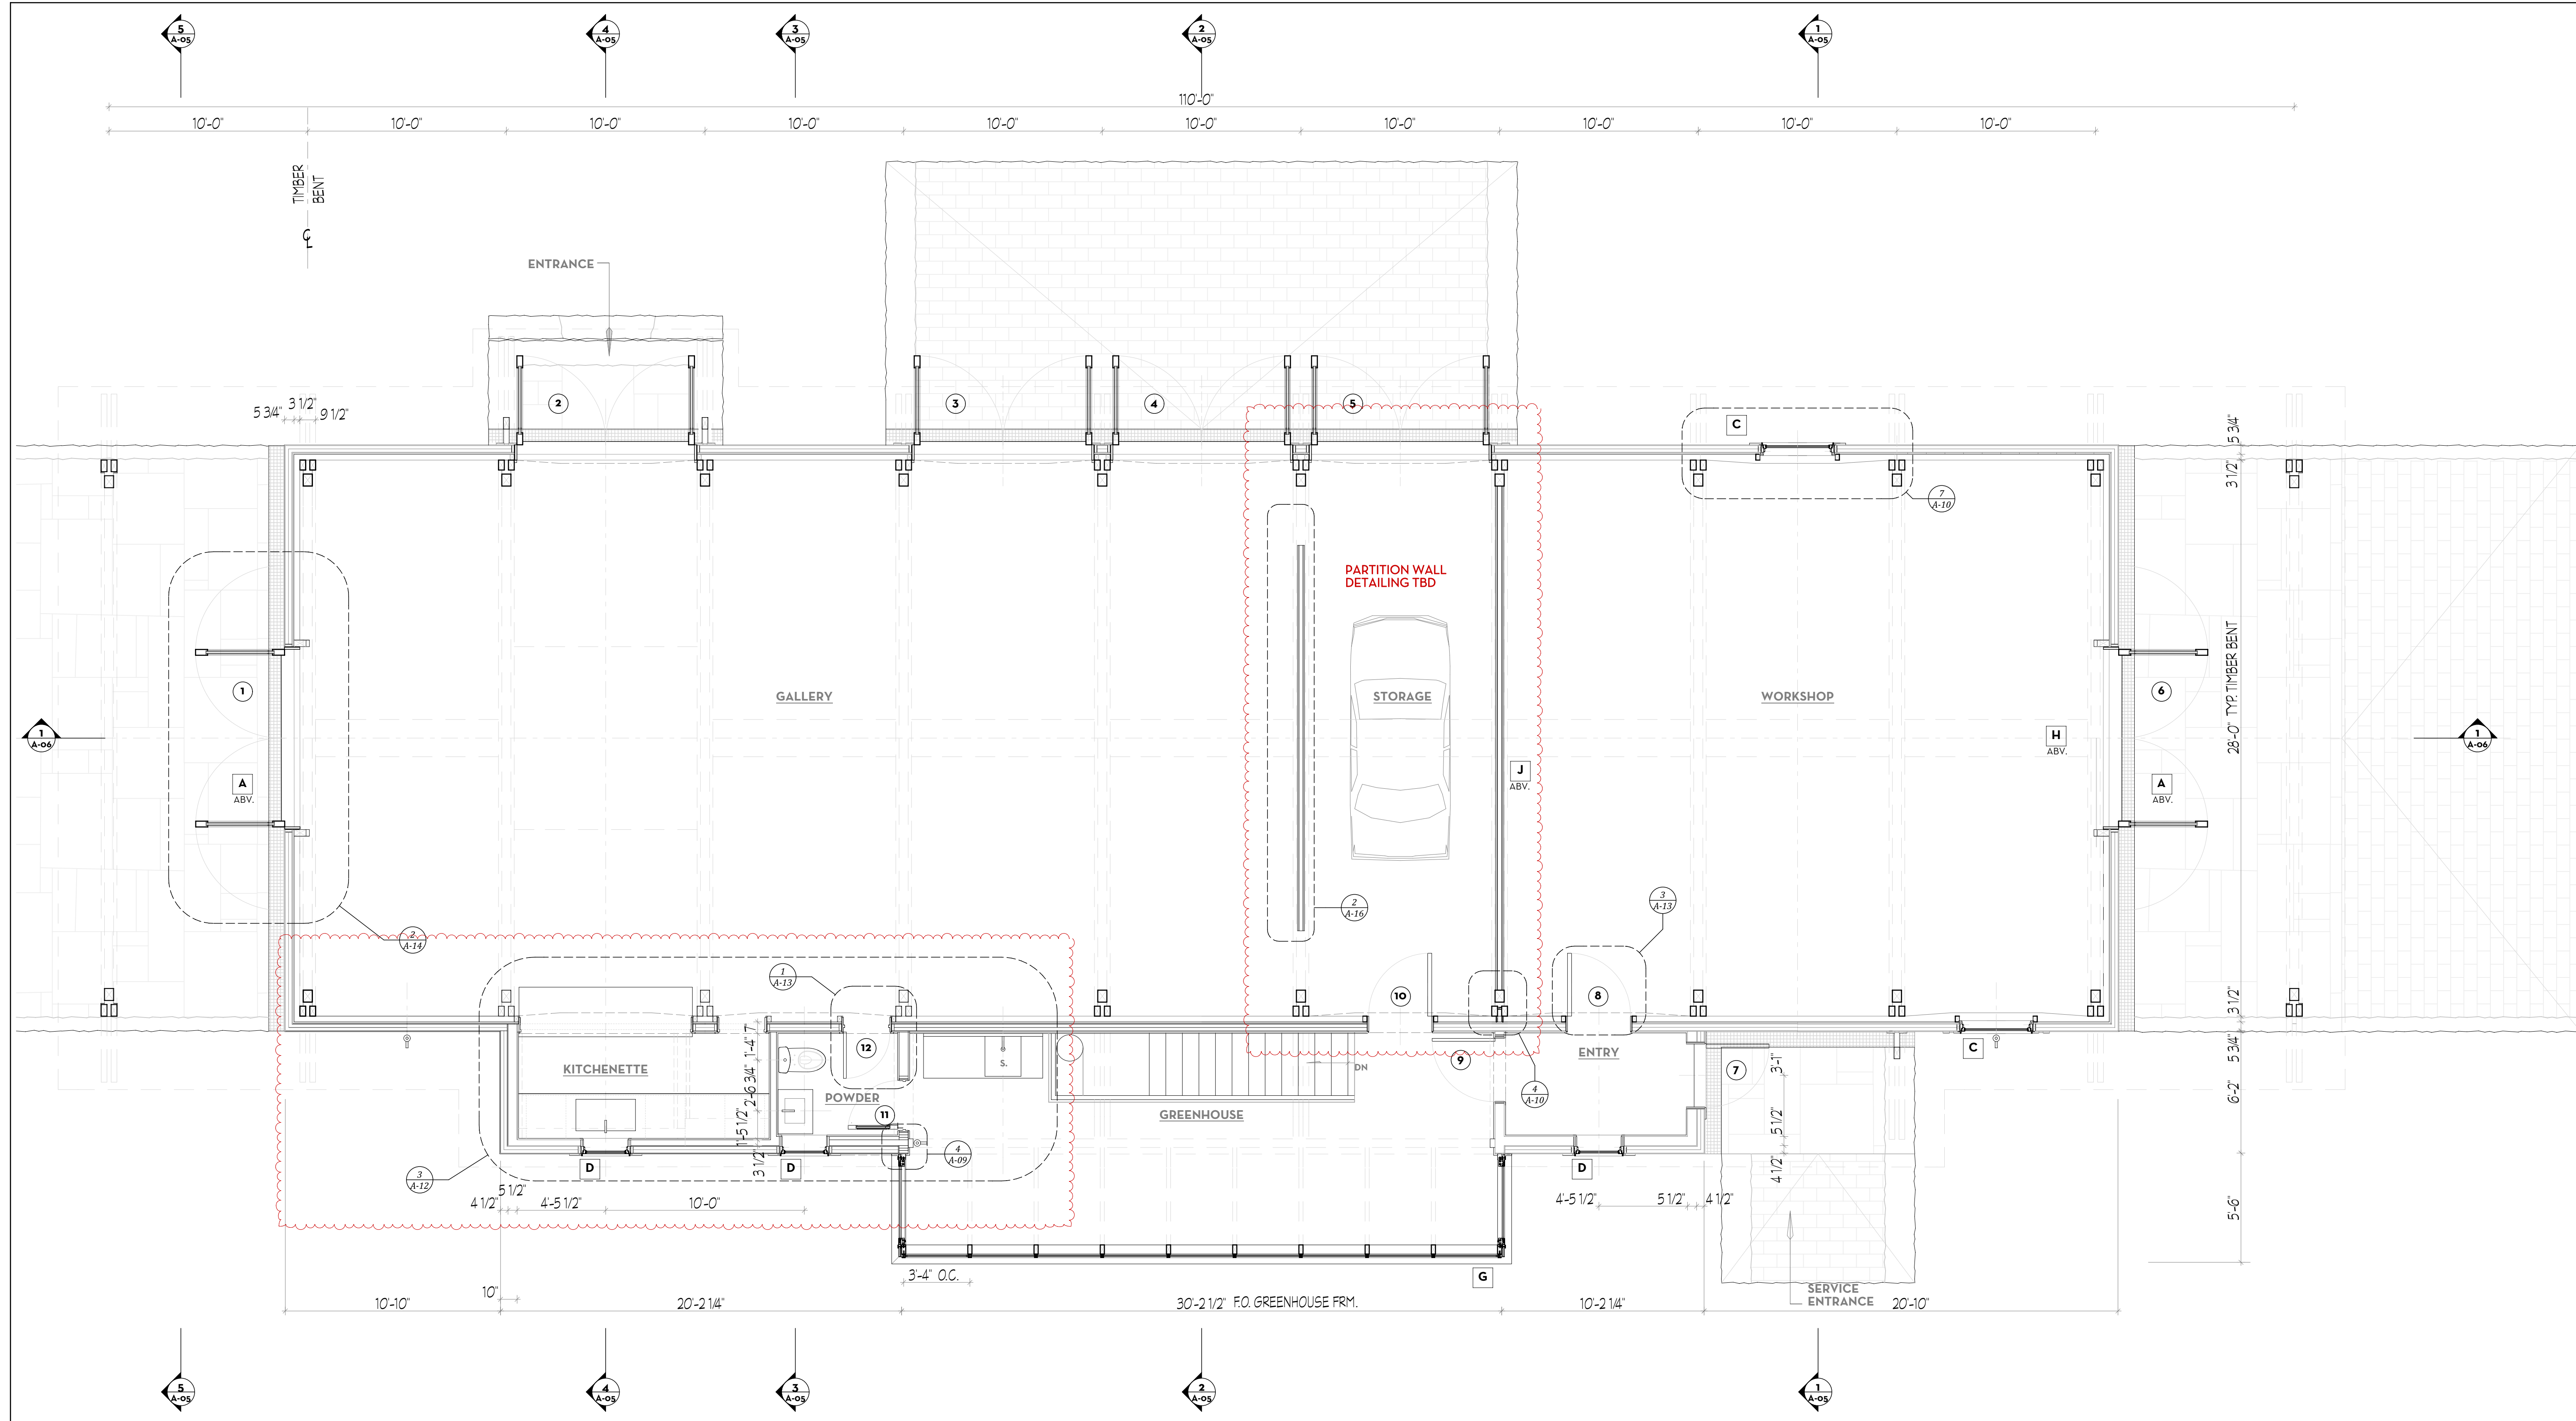

1 GROUND FLOOR PLAN
 SCALE: 1/4" = 1'-0"

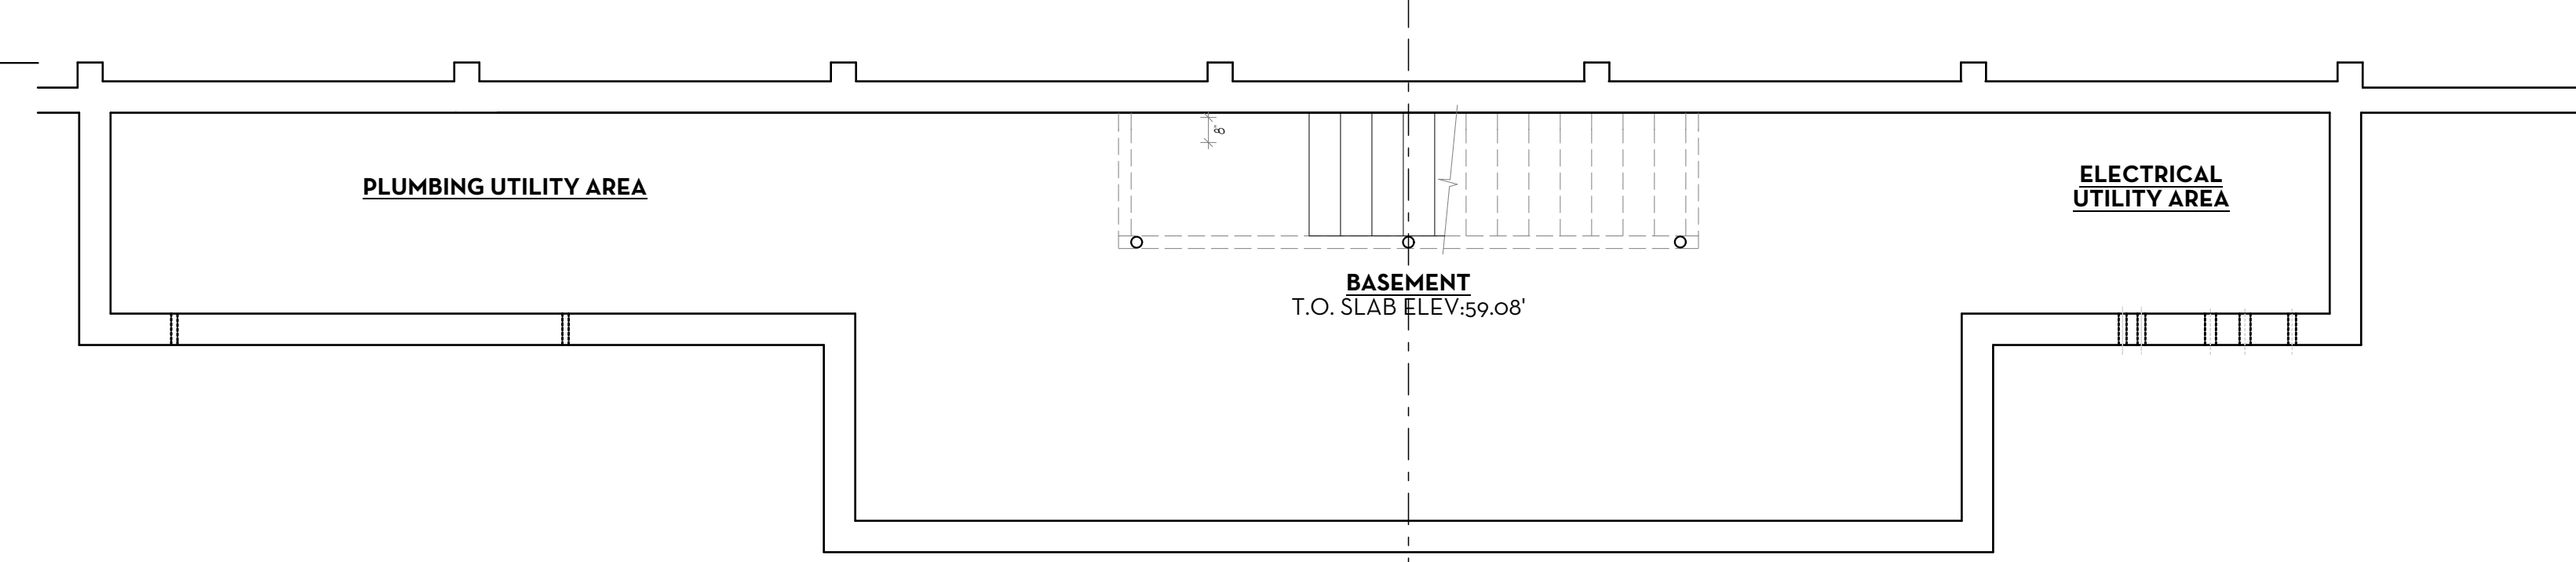

2 BASEMENT PLAN
 SCALE: 1/4" = 1'-0"

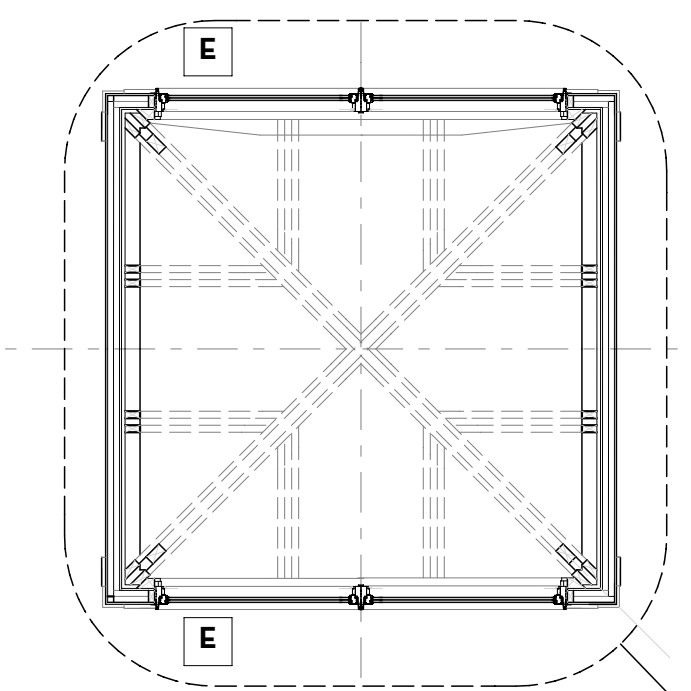

3 CUPOLA PLAN
 SCALE: 1/4" = 1'-0"


FLOOR PLANS
Stillpoint Meadows Barn
 Stillpoint Meadows Rd. West Tisbury, MA

Scale: As Noted


Date: 8/3/12
 Revision: Date & Type
 CONSTRUCTION SET: 03.20.12

Sheet:

A-01

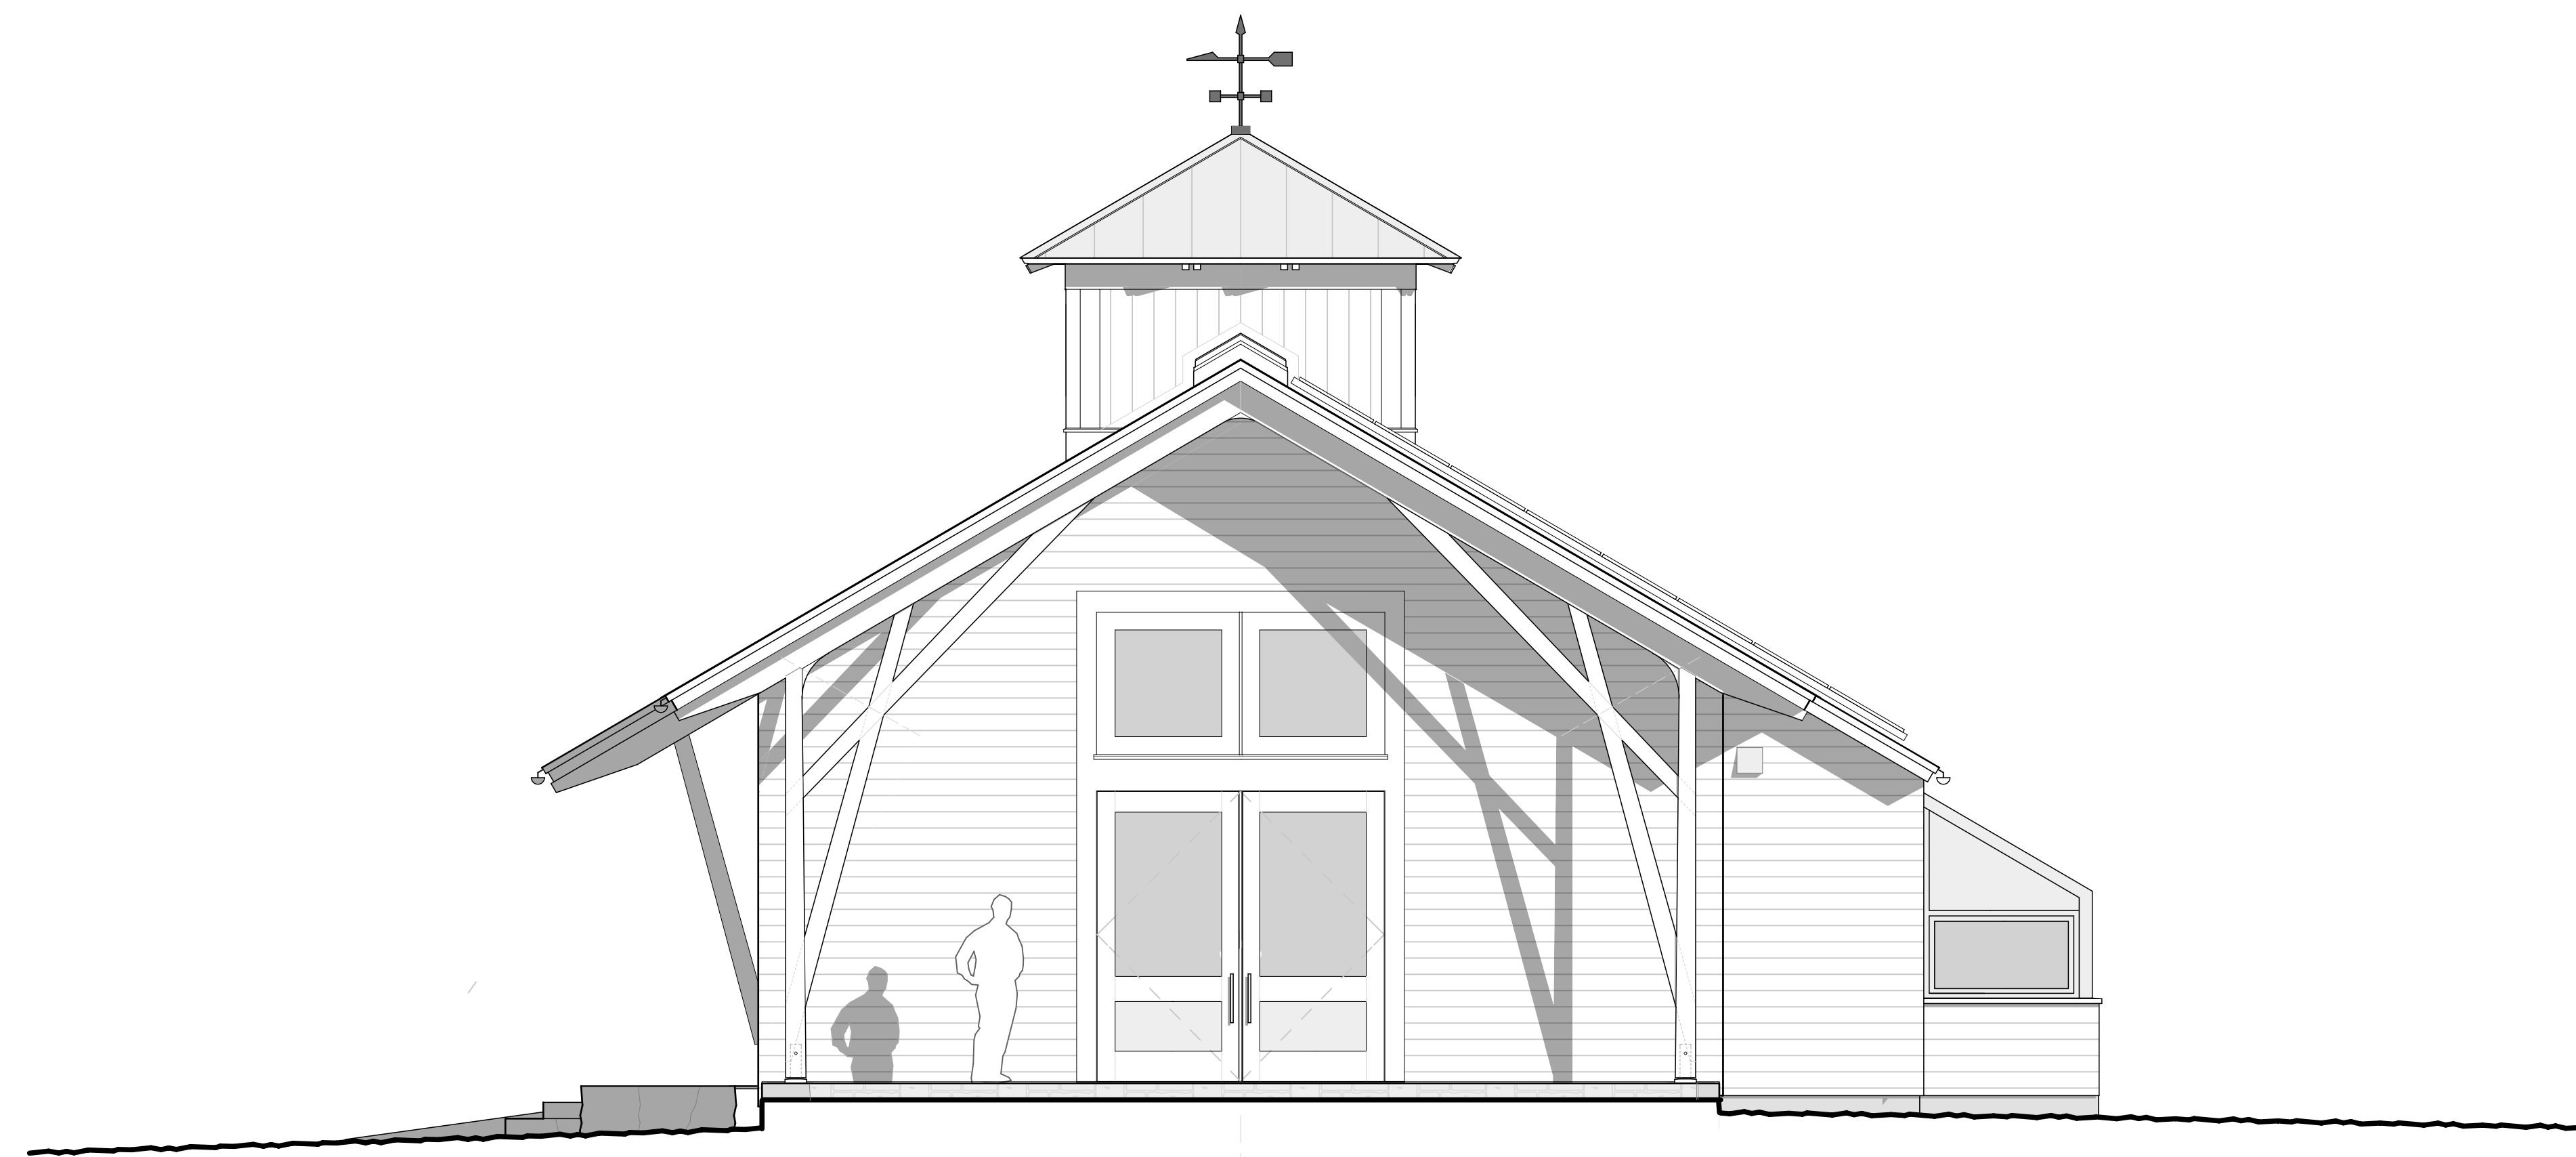

2 West Elevation
 SCALE: 1/4" = 1'-0"

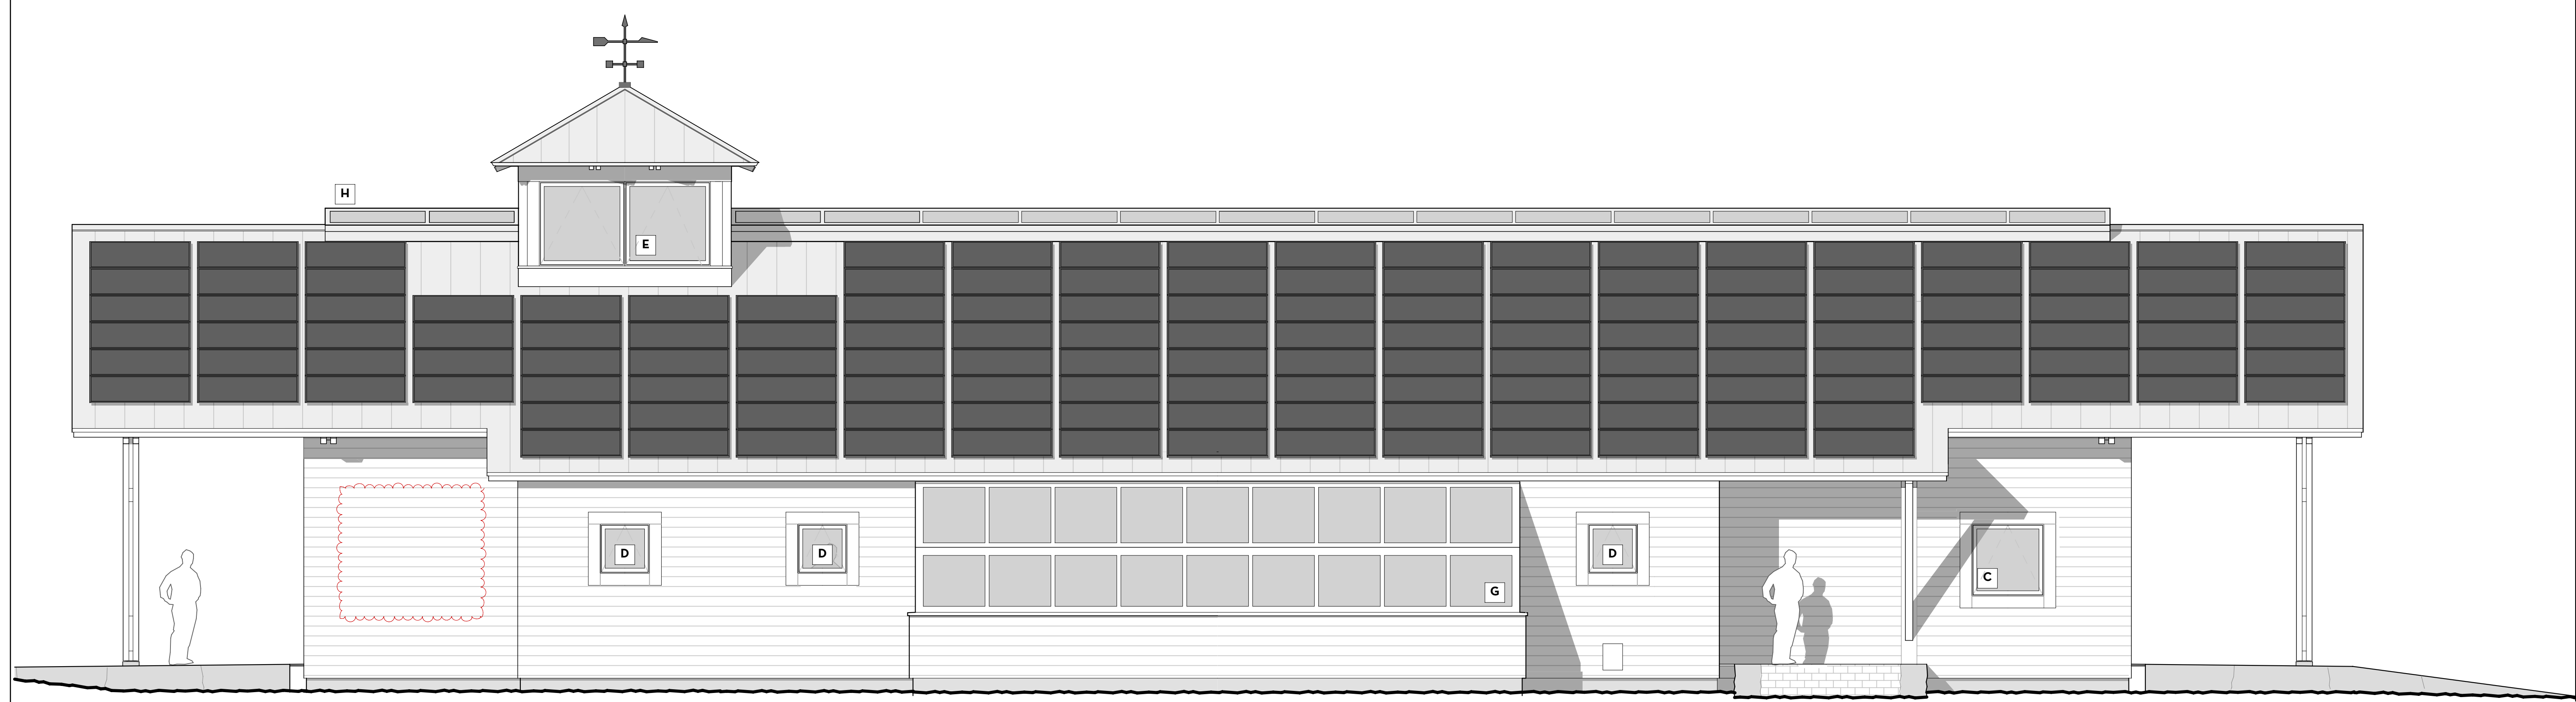


1 South Elevation
 SCALE: 1/4" = 1'-0"

South & West Elevations
Stillpoint Meadows Barn
 Stillpoint Meadows Rd. West Tisbury, MA


Date: 8/3/12
 Scale: As Noted
 Revision: Date & Type
 CONSTRUCTION SET: 03.20.12

Sheet:
A-03

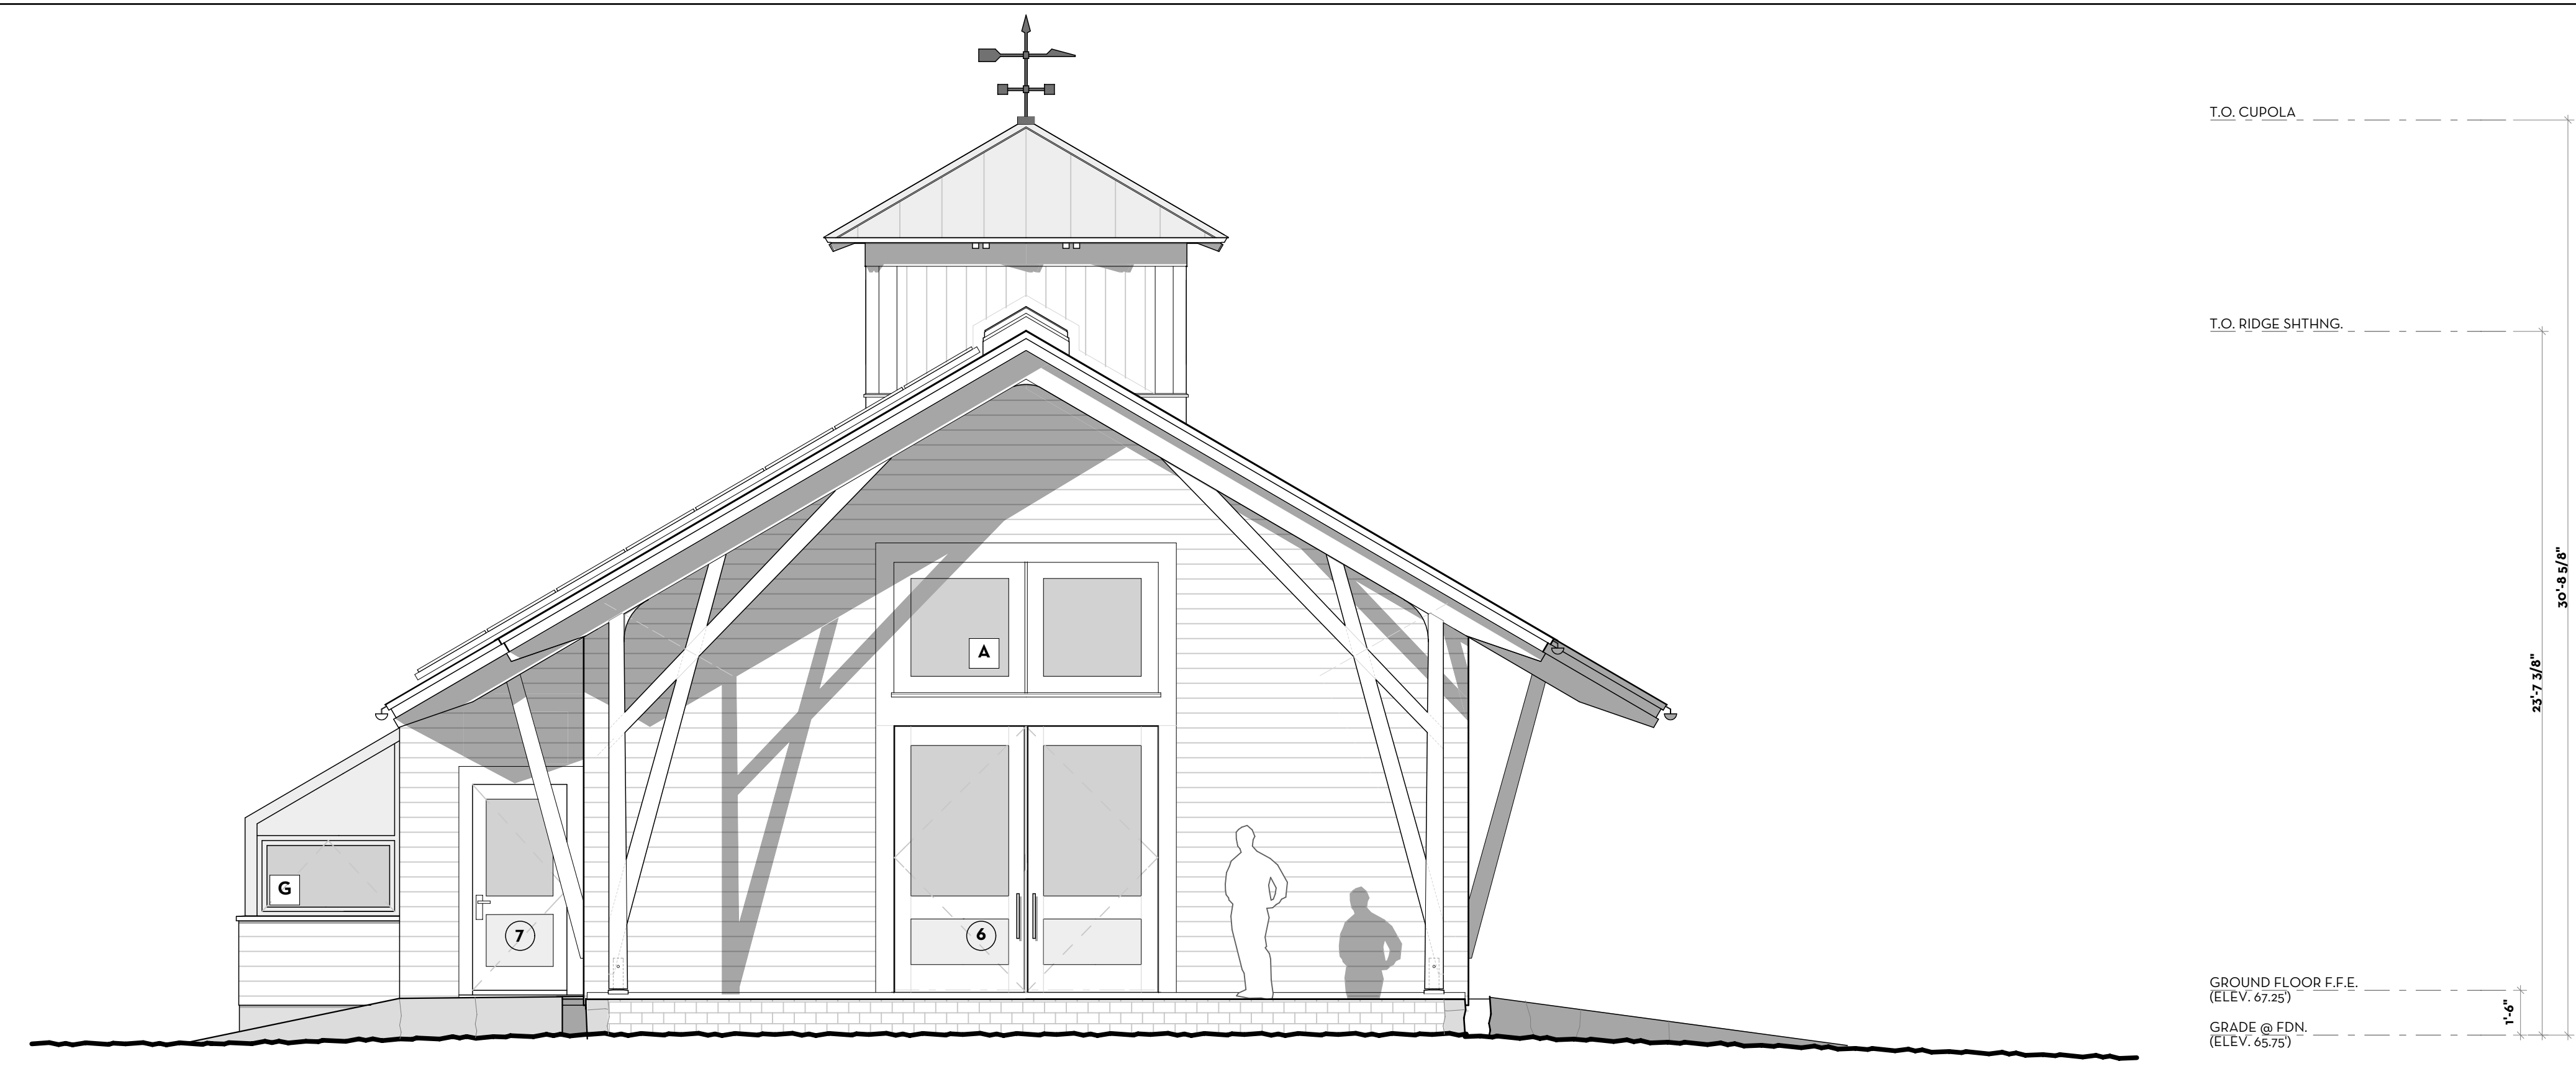

2 East Elevation

 SCALE: 1/4" = 1'-0"

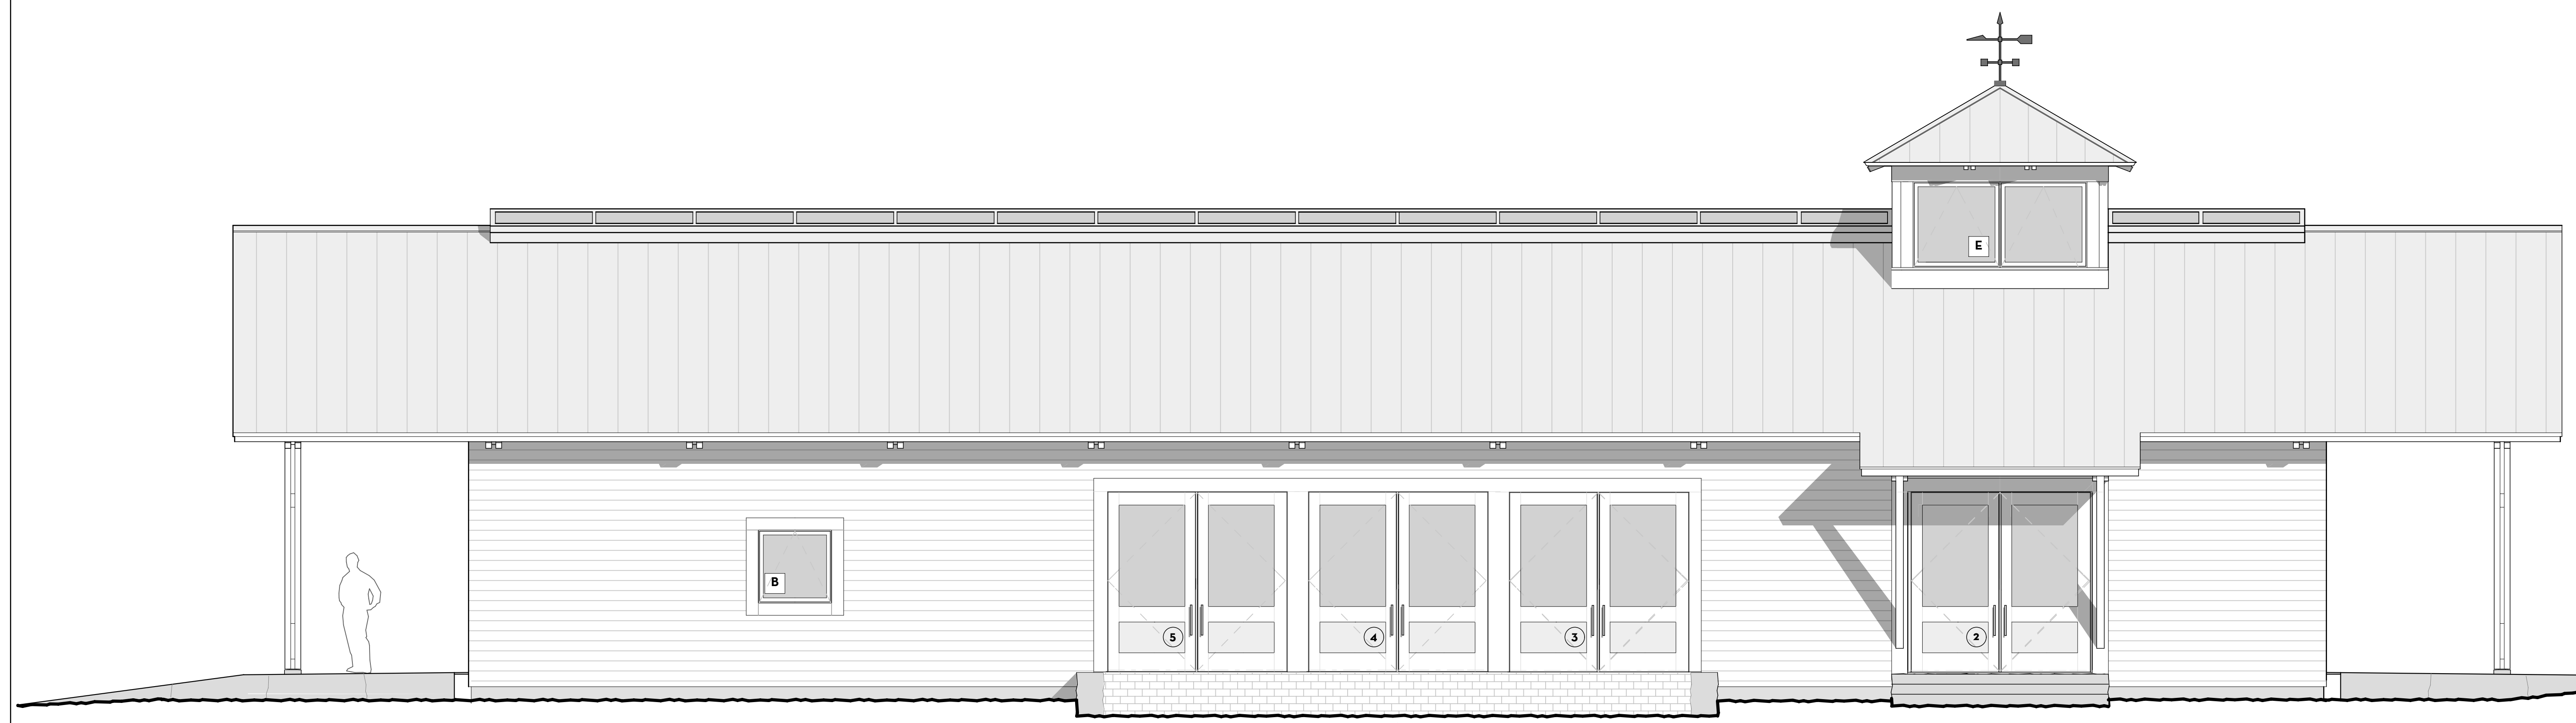

1 North Elevation

 SCALE: 1/4" = 1'-0"

North & East Elevations

Stillpoint Meadows Barn

 Stillpoint Meadows Rd. West Tisbury, MA

Date: 8/3/12

 Scale: As Noted

 Revision: Date & Type

 CONSTRUCTION SET: 03/20/12

Sheet:

A-04